



www.stgdesign.com
© 2019 STG Design, Inc. All Rights Reserved

STG Design, Inc.
211 Union Street
Nashville, TN 37201
615.248.4400

PROGRESS PRINT

11/12/21

 
Not for regulatory approval,
permitting, or construction.

Regulator's Name: David Johnson, AIA
Tennessee Registration Number: 35564



Union Deaderick Plaza
Union and Deaderick
Nashville, TN 37219

CLIENT LOGO



2 100% DD 11/12/21
1 50% DD 10/15/21


Issues

Project Number: 21.21300.00

Project Lead: CJ


MATERIALS PLAN

L-101

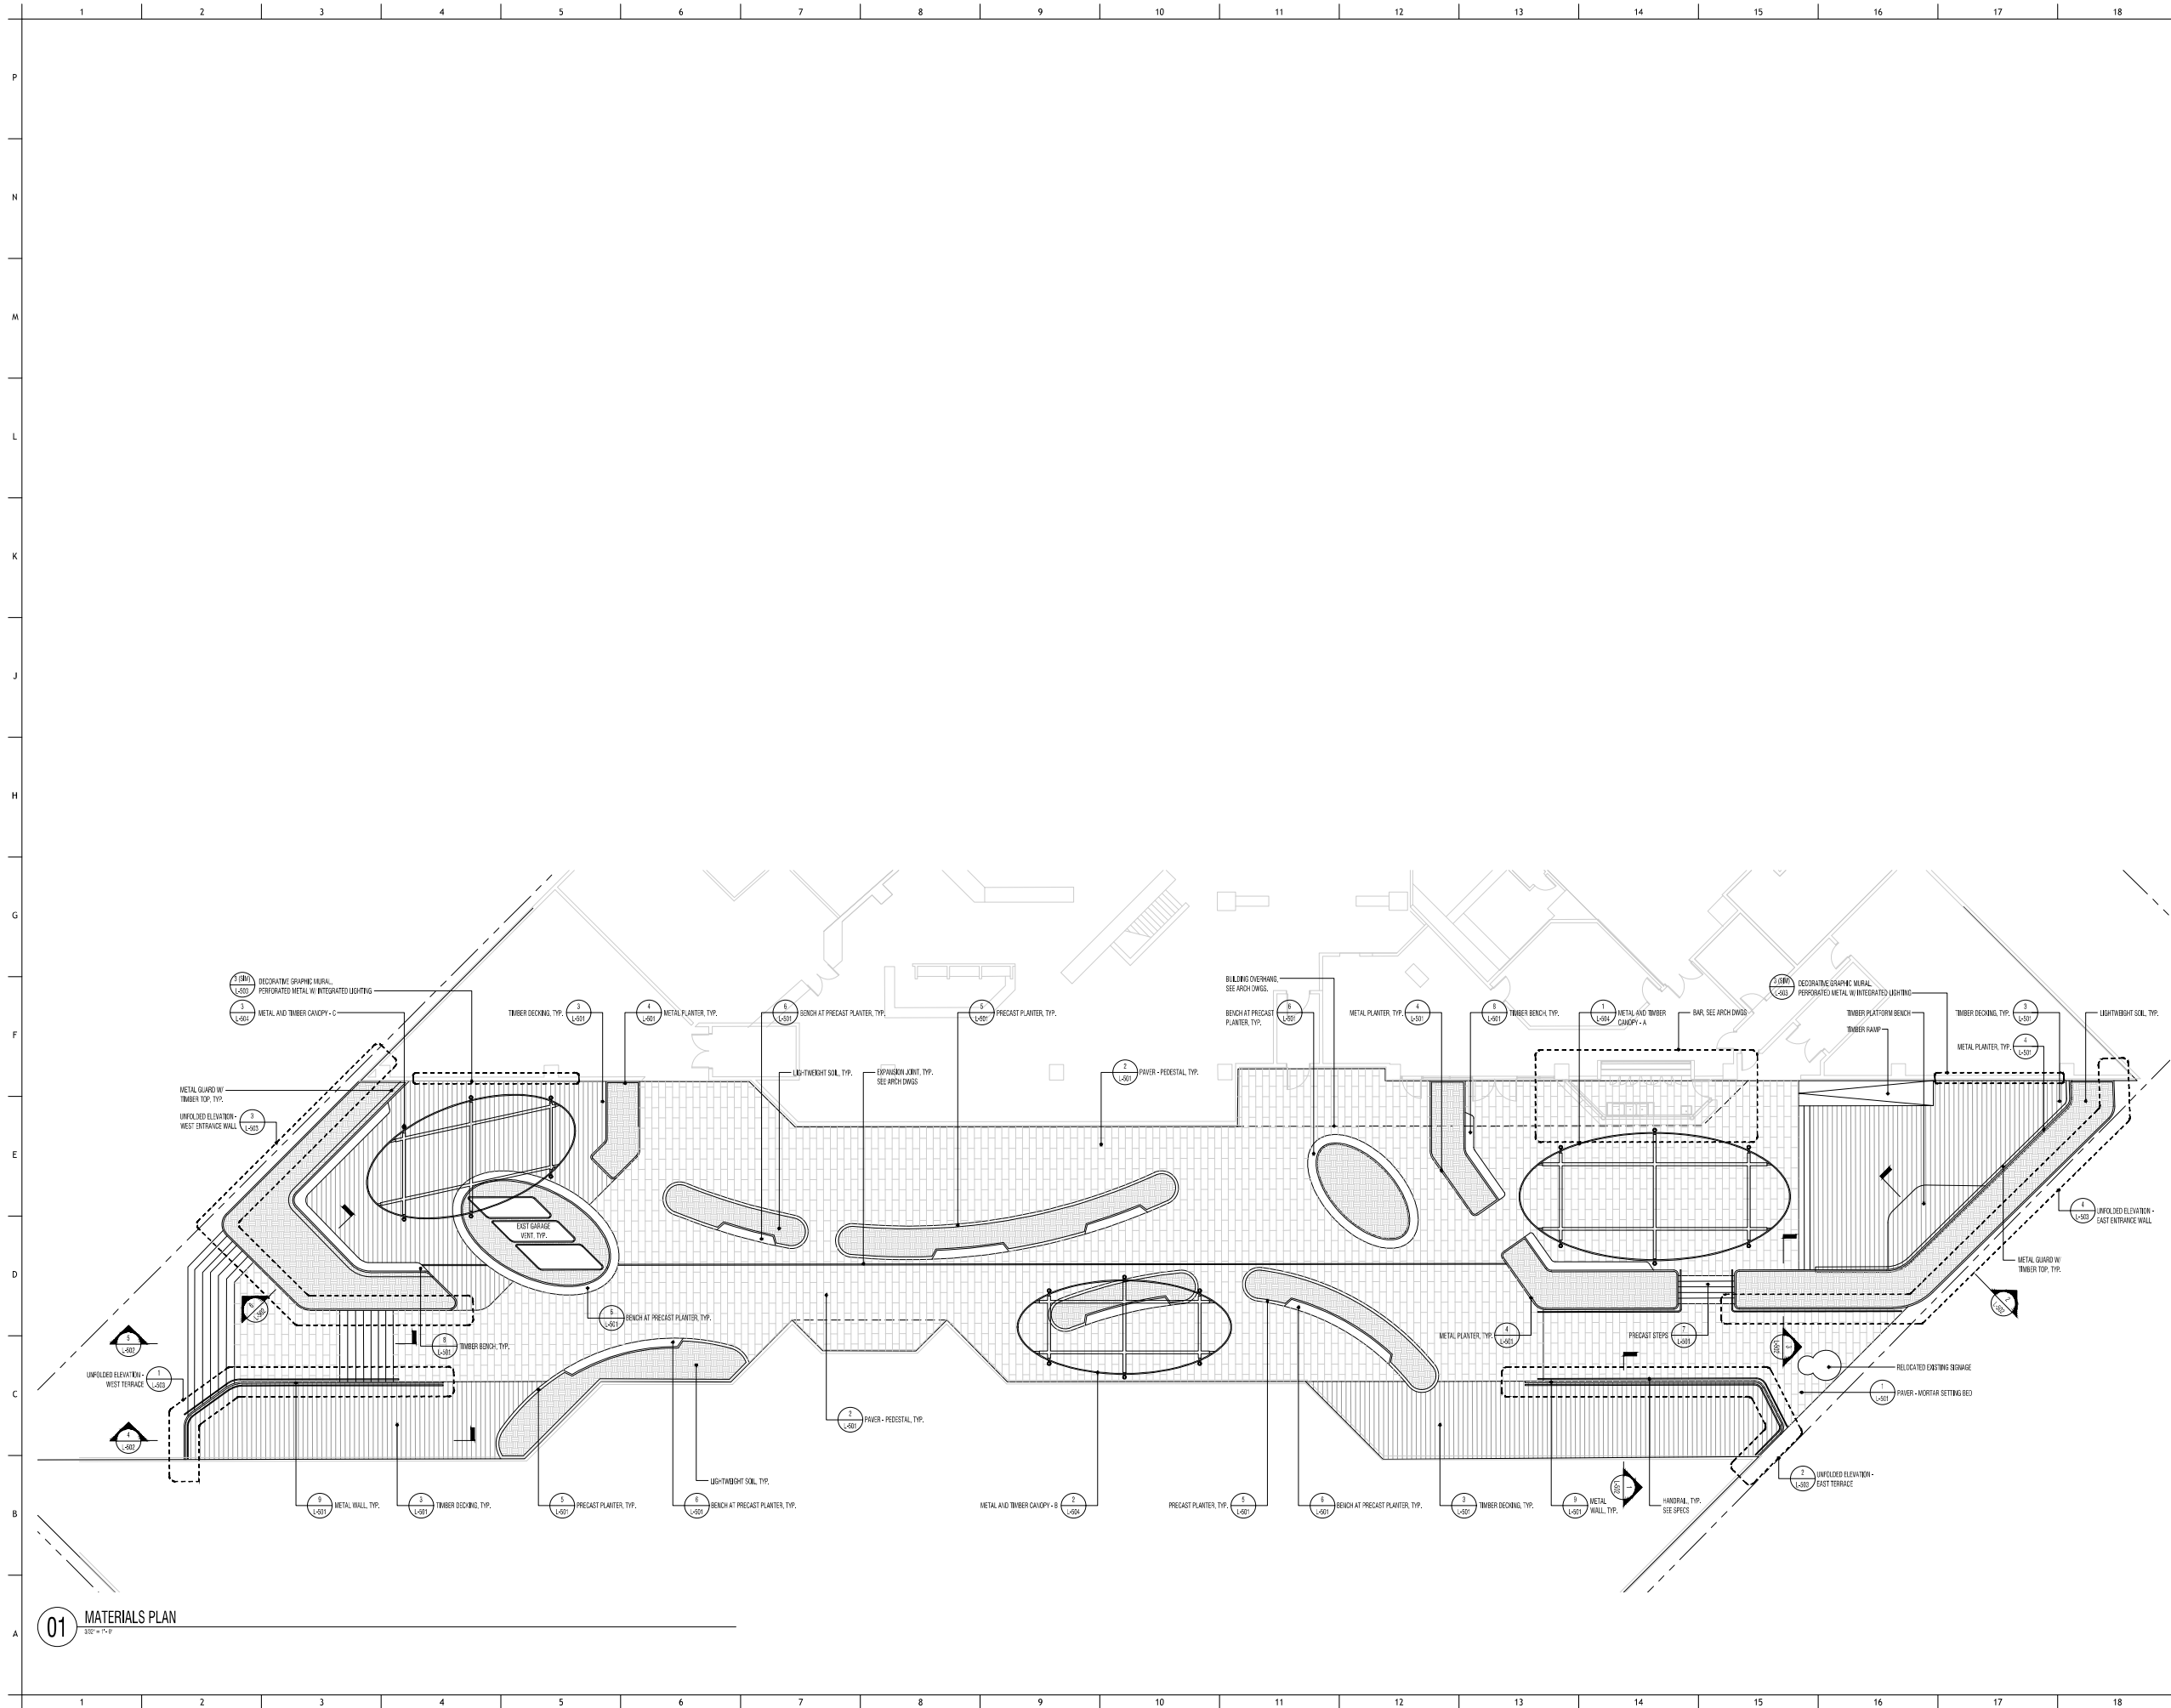

01 MATERIALS PLAN
20' = 1" = 0

Plot Date: 9/24/2021 3:53:05 PM
General Plot File: \\BMS-3605-STG\Design\21.21300.00\Union Deaderick Plaza\Agencies\Progress\Prints\01 Materials Plan.rvt
User: CJ
Plot Path: \\BMS-3605-STG\Design\21.21300.00\Union Deaderick Plaza\Agencies\Progress\Prints\01 Materials Plan.rvt

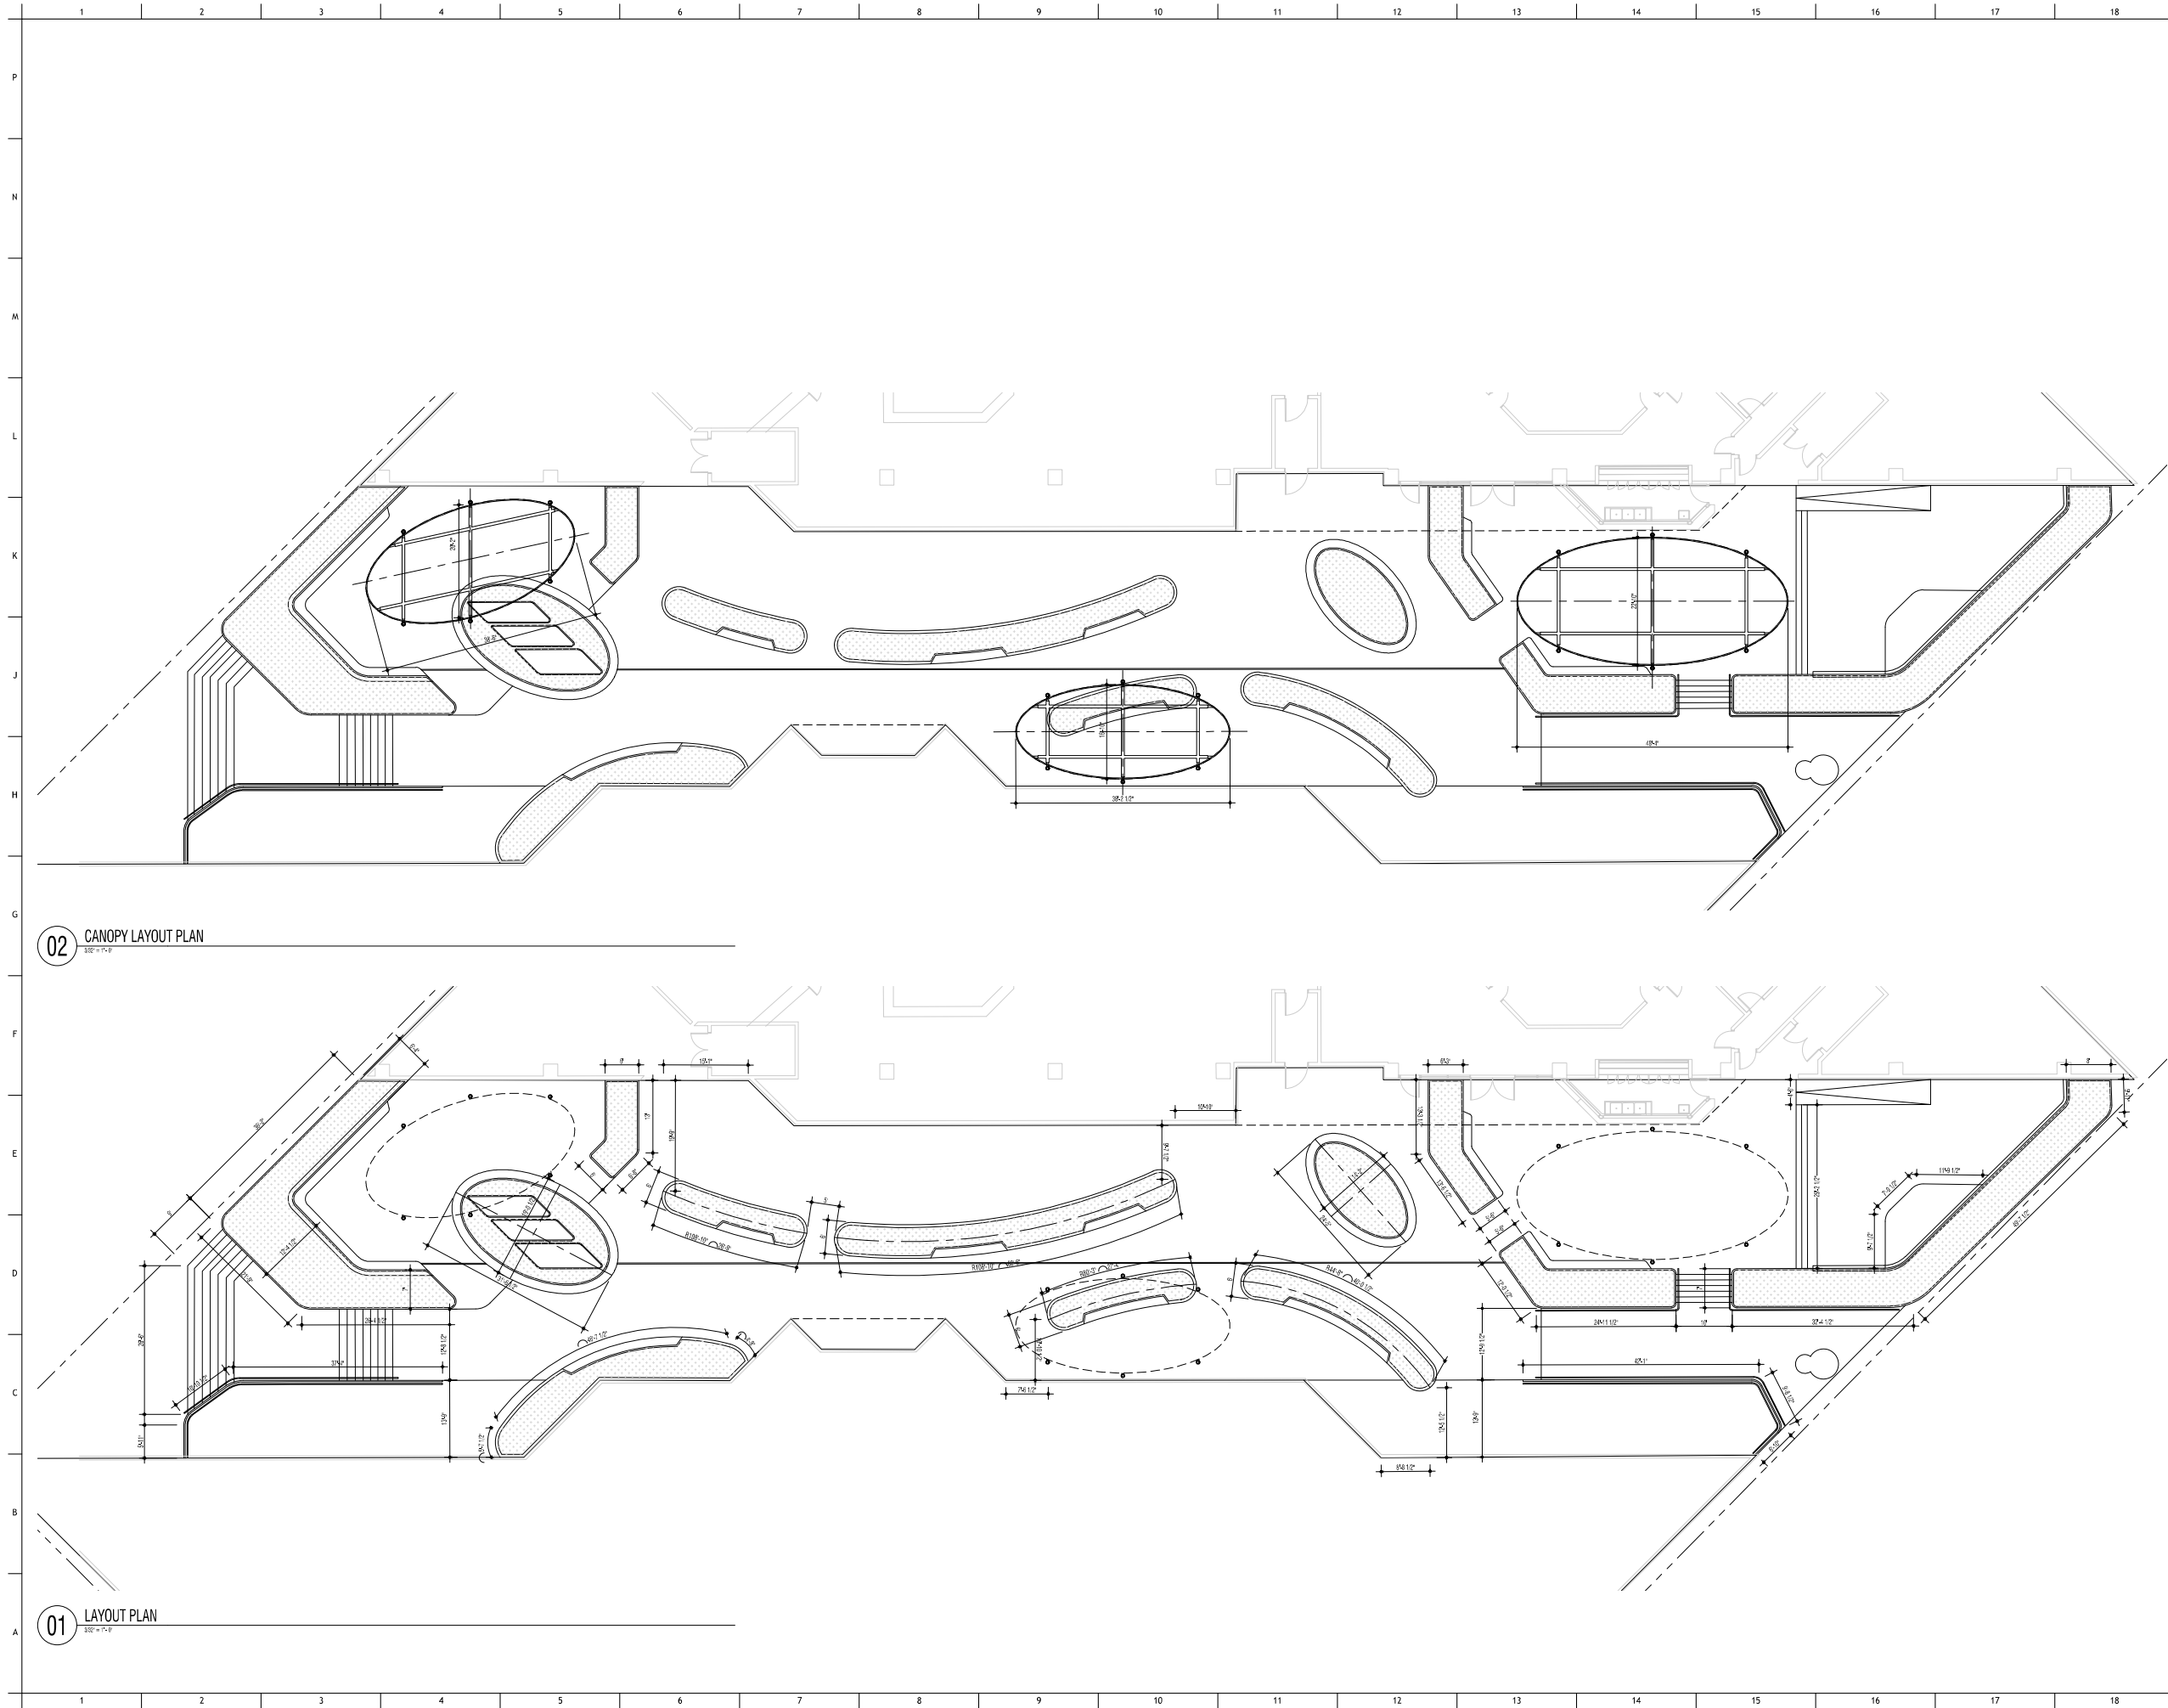

02 CANOPY LAYOUT PLAN
1/8" = 1'-0"

01 LAYOUT PLAN
1/8" = 1'-0"



www.stgdesign.com
© 2019 STG Design, Inc. All Rights Reserved

STG Design, Inc.
211 Union Street
Nashville, TN 37201
615.248.4400

PROGRESS PRINT

11/12/21

 
Not for regulatory approval,
permitting, or construction.

Regulator's Name: David Johnson, AIA
Tennessee Registration Number: 35564



Union Deaderick Plaza
Union and Deaderick
Nashville, TN 37219

CLIENT LOGO



2 100% DD 11/12/21

1 50% DD 10/15/21

Issues


Project Number: 21.21300.00

Project Lead: CJ

LAYOUT PLAN

L-201

Project Name: 9/15/2020 11:53:05 AM
 General Plot File: 01 - 304 - STG Design - 112 - 200 - 00 - Union Deaderick Plaza - Progress Print - STG Design
 User: Mr. John - 888 - 860 - 0751 - 1370000 - Union Deaderick Plaza - Union Deaderick Plaza - 4/8/2021 10:11 AM

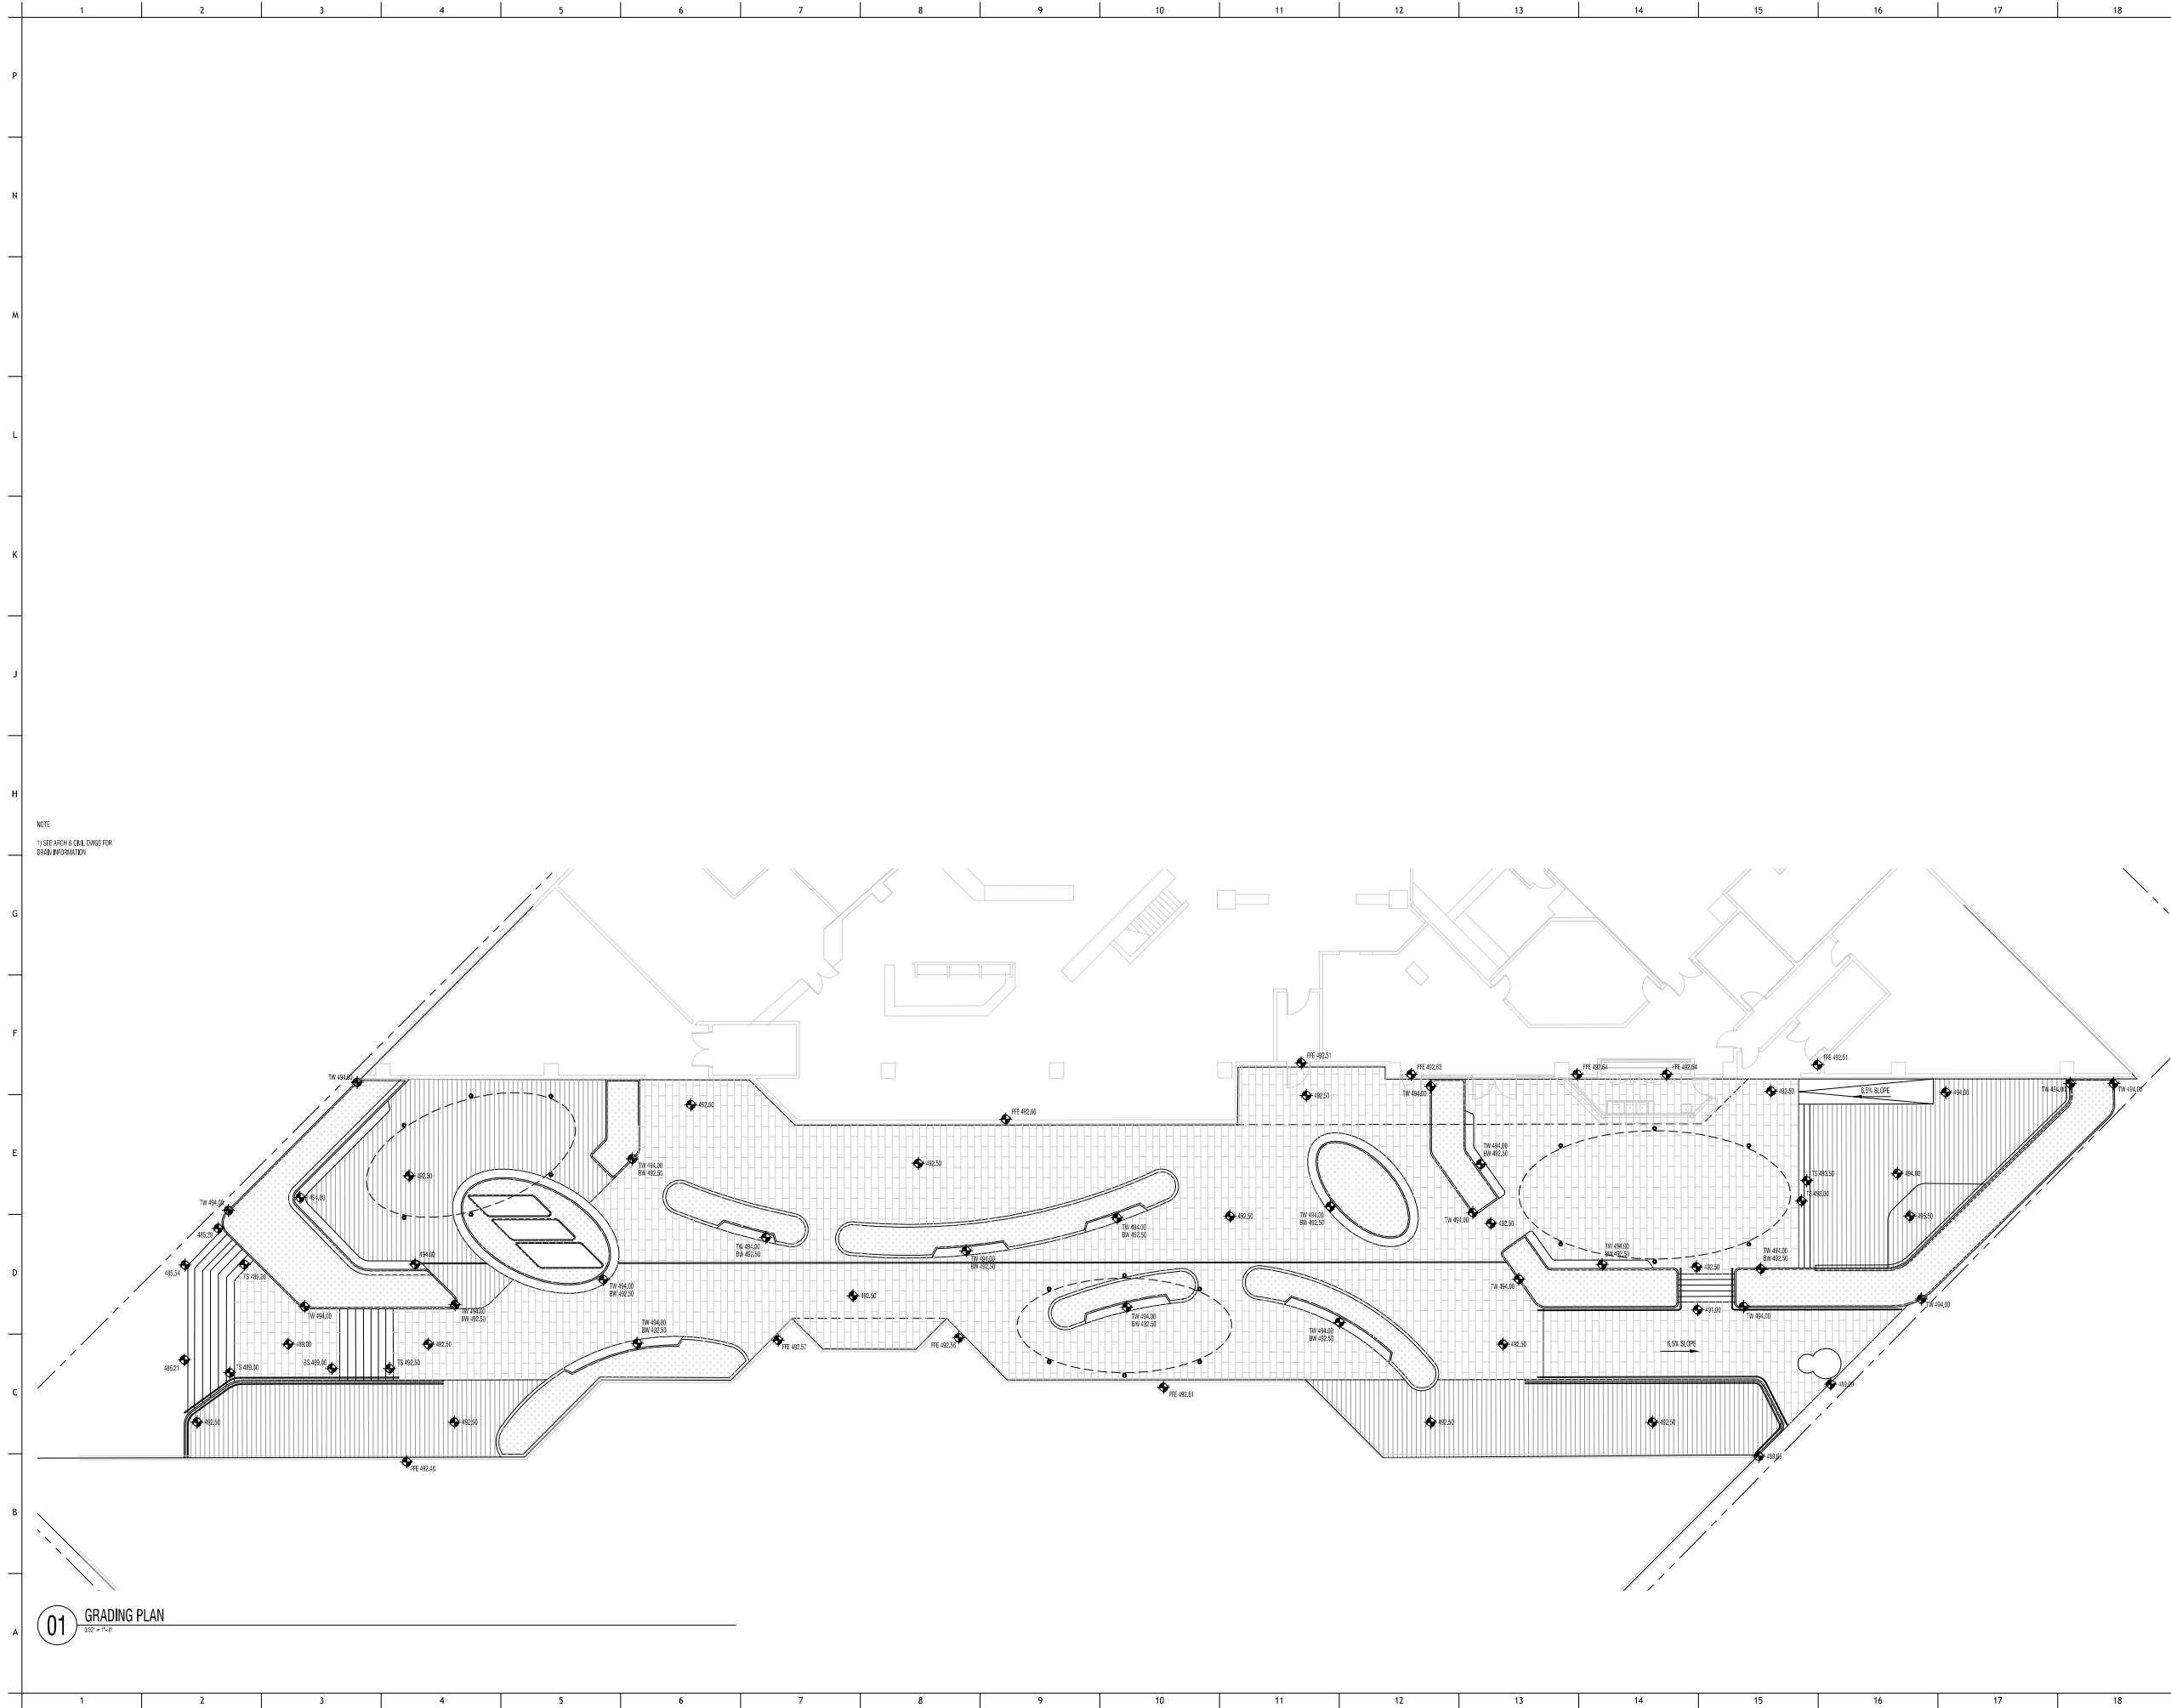

NOTE:
1) SEE ARCH & CIVIL DWGS FOR DRAIN REQUIREMENTS

01 GRADING PLAN
20' = 1'-0"



www.stgdesign.com
© 2019 STG Design, Inc. All Rights Reserved

STG Design, Inc.
211 Union Street
Nashville, TN 37201
615.248.4400

PROGRESS PRINT

11/12/21

 
Not for regulatory approval,
permitting, or construction.

Regulator's Name: David Johnson, AIA
Tennessee Registration Number: 35564



Union Deaderick Plaza
Union and Deaderick
Nashville, TN 37219

CLIENT LOGO



2 100% DD 11/12/21
1 50% DD 10/15/21

Issues

Project Number: 21-21300-00

Project Lead: CJ

GRADING PLAN

L-202



www.stgdesign.com
 615.248.4400

 
STG Design, Inc.
 211 Union Street
 Nashville, TN 37201
 615.248.4400

PROGRESS PRINT
 11/12/21
 Not for regulatory approval,
 permitting, or construction.
 Registrar's Name: David Johnson, AIA
 Tennessee Registration Number: 33264



Union Deaderick Plaza
 Union and Deaderick
 Nashville, TN 37219

CLIENT LOGO



2 100% DD 11/12/21
 1 50% DD 10/15/21

Issues

Project Number: 21.21300.00


Project Lead: CJ

PLANTING PLAN

L-301


TREES	BOTANICAL NAME	COMMON NAME	QTY	ROOT	SIZE	SPACING	LIGHT/SOIL	CHARACTERISTICS	
Bn	Betula nigra 'Sura Heat'	River Birch multi stem		B&B	8'-10' HT	see plan	sun/prt shade	multi stem 20x15'	
Gt	Gleditsia triacanthos	Honey Locust		B&B	3" cal	see plan	sun/prt shade	small leaf, dappled light	
To	Thuja occidentalis	Emerald Green Arborvitae		B&B	5-7' HT	see plan	sun/prt shade	8'x3' evergreen	
Pt	Pinus thunbergii 'thunderhead'	Japanese Black Pine							
Ap	Acer palmatum 'virdis'	Japanese Maple		B&B	8'-10' HT	see plan	part shade	10'x10'	
CC	Cercis canadensis	Redbud		B&B	8'-10' HT	see plan	sun/prt shade	Flowering native	
Ac	Amelanchier canadensis	Serviceberry		B & B	8'-8' HT	see plan	sun/ shade	12'x12'	
J	Juniperus chinensis 'torulosa'	Hollywood Juniper		B&B	6-8' HT	as noted	full sun	10-12'x10'	
TREE QTY: 14									
SHRUBS	BOTANICAL NAME	COMMON NAME	QTY	ROOT	SIZE	SPACING	LIGHT/SOIL	CHARACTERISTICS	
Vp	Viburnum plicatum tomentosum tree form	Doublefile Viburnum		Cont.	10 gal	see plan	sun/shade	8'x8' white flws	
Bk	Buxus microphylla var koronana	Korean Boxwood		Cont.	5 gal	see plan	sun/prt shade	3-4'x4-6-5' evergreen	
Pl	Prunus laurocerasus 'schipkaensis'	Skyp Laurel		Cont.	7 gal	see plan	sun/prt shade	6'x3-4'	
PS	Pinus strobus 'Dwarf'	Dwarf White Pine							
HQ	Hydrangea quercifolia	Oakleaf Hydrangea		Cont.	34"-36"HT	see plan	sun/prt shade	4-6'x5-8' white flwr	
Pmp	Pinus mugo 'pumilio'	Mugo Pine		Cont.	5 gal	as noted	full sun	3'x4'	
SHRUB QTY: 735 SF									
PERENNIALS	BOTANICAL NAME	COMMON NAME	QTY	ROOT	SIZE	SPACING	LIGHT/SOIL	CHARACTERISTICS	
Jf	Athyrium filix-femina	Lady Fern		Cont.	2 gal	see plan	shade	30" H	
Hma	Hakonechloa macro 'laureola'	Hakone Grass		Cont.	2 gal	see plan	shade	18" x 18"	
A	Astilbe chinensis	White		Cont.	1 gal	see plan	shade	flowering	
Pls	Perovskia "Little Spire"	Russian sage		Cont.	1 gal	see plan	shade	purple flower	
H	Hosta "sum and substance"	Hosta		Cont.	3 gal	see plan	shade	30" H	
E	Echinacea alba	wh/purp Coneflower		Cont.	2 gal	see plan	sun/prt shade	24" H white flower	
L	Liatis spicata "Kobold"	Liatis		Cont.	2 gal	see plan	full sun	24" H purp flower	
S	Sedum	Stonecrop "Autumn Joy"		Cont.	2 gal	see plan	full sun	24"	
A	Allium "lucy ball" Fritillaria	Allium		Bulb	2 gal	as noted	full sun	36" H	
N	Nepeta "walkers low"	Cammet		Cont.	2 gal	see plan	full sun	24" H purp flower	
COVERVINES	BOTANICAL NAME	COMMON NAME	QTY	ROOT	SIZE	SPACING	LIGHT/SOIL	CHARACTERISTICS	
Lm	Liriope muscari "big blue"	Lily Turf		Cont.	1gal	12" O.C.	sun/shade	evergreen	
Hh	Hedra Helix	English Ivy		trailing	Cont.	1 gal	10" OC	sun/shade	evergreen
Jh	Juniperus horizontalis 'blue rug'	Blue Rug Juniper		Cont.	2 gal	18" OC	sun/shade	evergreen	
Lv	Liriope muscari "variegata"	Lily Turf Variegated		Cont.	1 gal	12" O.C.	sun/shade	evergreen	
C	Clematis "Etolie Violette" staked	Clematis staked		Cont.	3 gal	see plan	sun/shade	deep purple flower staked	
Hp	Hydrangea anomala petiolaris staked	Climbing Hydrangea		Cont.	5 gal	see plan	sun/shade	climbing white flower	
Hhs	Hedra Helix staked	English Ivy staked		Cont.	3 gal	see plan	sun/shade	evergreen	
GRASSES	BOTANICAL NAME	COMMON NAME	QTY	ROOT	SIZE	SPACING	LIGHT/SOIL	CHARACTERISTICS	
Ms	Miscanthus sinensis 'Morning Light'	Maiden Grass		Cont.	3 gal	24" OC	sun/prt shade	4'x3'	
Pa	Pennisetum alopecuroides	Fountain Grass		Cont.	3 gal	18" OC	sun/prt shade	18"x18"	
Ca	Calamagrostis x acutifolia "Karl Foerster"	Feather Reed Grass		Cont.					
Fah	Pennisetum alopecuroides 'Hameln'	Fountain Grass		Cont.	3 gal	18" OC	sun/shade	2'x2'	
Fab	Pennisetum alopecuroides 'Little Bunny'	Dwarf Fountain Grass		Cont.	3 gal	18" OC	sun/shade	2'x2'	
Pv	Panicum variegatum "heavy metal"	Switch Grass		Cont.	3 gal	3' O.C.	sun/shade	3'x2'w	
PERENNIALS & GRASSES QTY: 1,715 SF									

02 PLANTING SCHEDULE

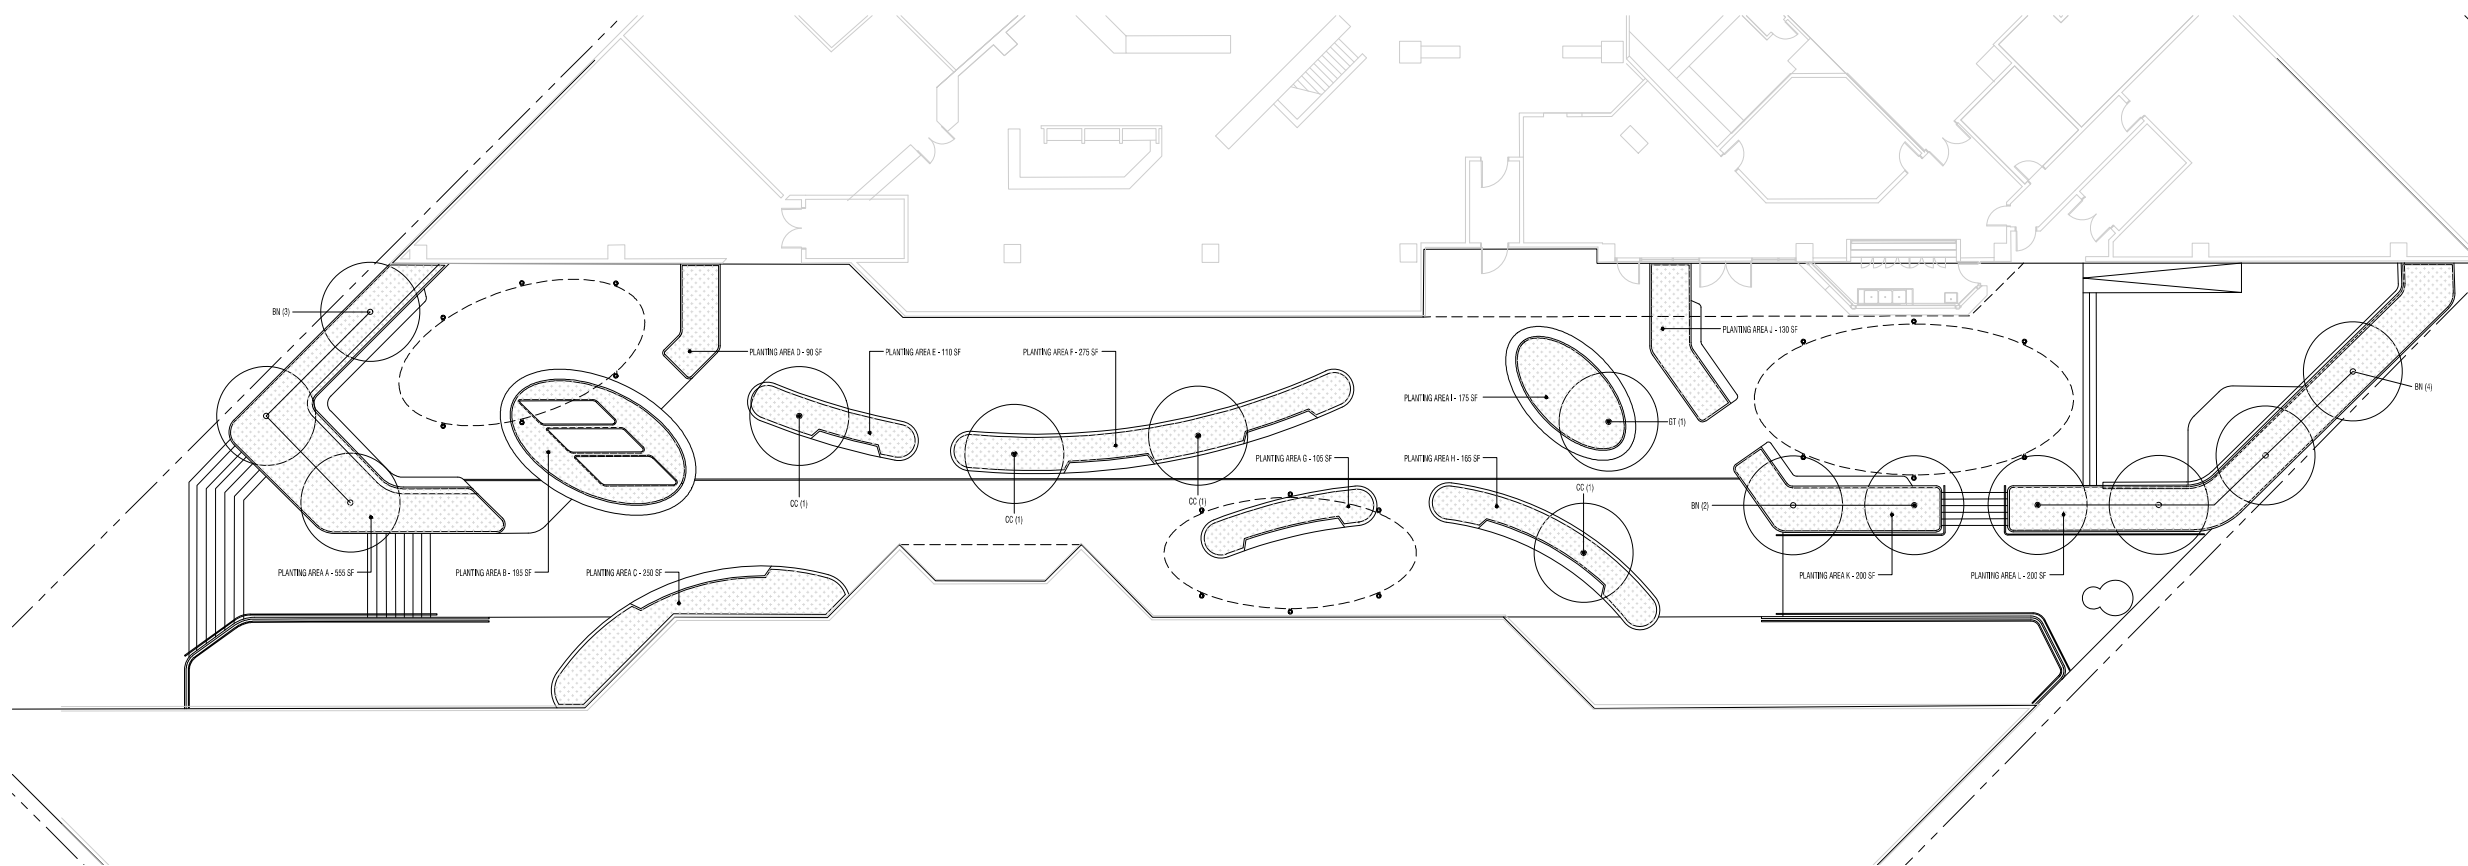

01 PLANTING PLAN

Plant Date: 9/24/2021 3:50:05 PM
 General Plot Note: 1. All plants shall be installed in accordance with the planting schedule and site plan.
 2. All plants shall be installed in accordance with the planting schedule and site plan.
 3. All plants shall be installed in accordance with the planting schedule and site plan.
 4. All plants shall be installed in accordance with the planting schedule and site plan.
 5. All plants shall be installed in accordance with the planting schedule and site plan.
 6. All plants shall be installed in accordance with the planting schedule and site plan.
 7. All plants shall be installed in accordance with the planting schedule and site plan.
 8. All plants shall be installed in accordance with the planting schedule and site plan.
 9. All plants shall be installed in accordance with the planting schedule and site plan.
 10. All plants shall be installed in accordance with the planting schedule and site plan.
 11. All plants shall be installed in accordance with the planting schedule and site plan.
 12. All plants shall be installed in accordance with the planting schedule and site plan.
 13. All plants shall be installed in accordance with the planting schedule and site plan.
 14. All plants shall be installed in accordance with the planting schedule and site plan.
 15. All plants shall be installed in accordance with the planting schedule and site plan.
 16. All plants shall be installed in accordance with the planting schedule and site plan.
 17. All plants shall be installed in accordance with the planting schedule and site plan.
 18. All plants shall be installed in accordance with the planting schedule and site plan.

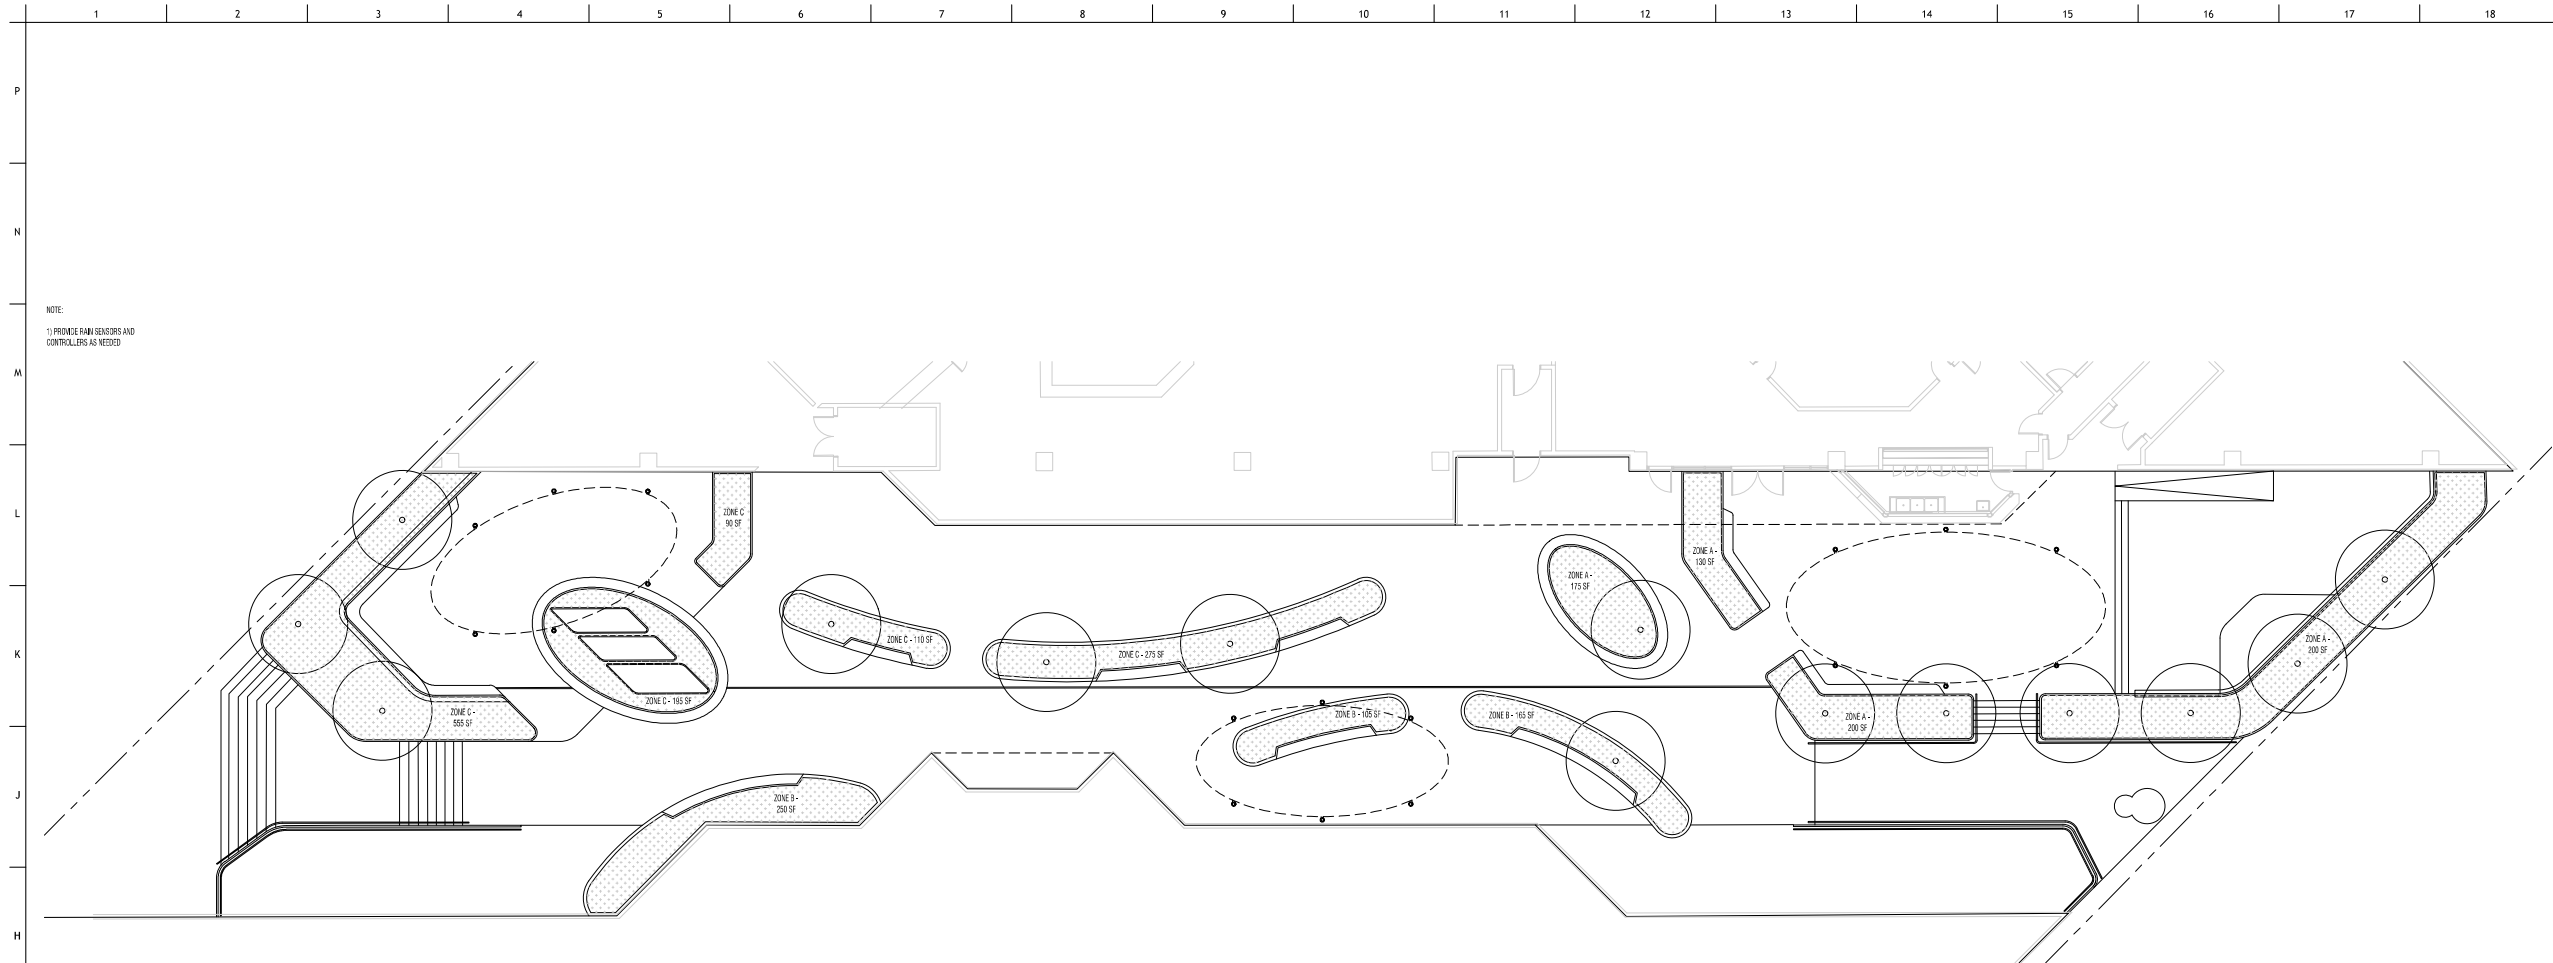


03 IRRIGATION PLAN
3/2" = 1'-0"



LIGHTING SCHEDULE	DESCRIPTION
LXA	Integrated LED strip light
LXB	Catenary lights
LXC	Panel uplight
LXD	Integrated LED strip light at handrail
LXE	Integrated canopy lights

NOTE:
1) FROM PREPARED METAL PANELS, ASSUME A GRID OF INTEGRATED LED STRIPS WITH A USER TO CREATE CONSISTENT ILLUMINATION

02 LIGHTING SCHEDULE

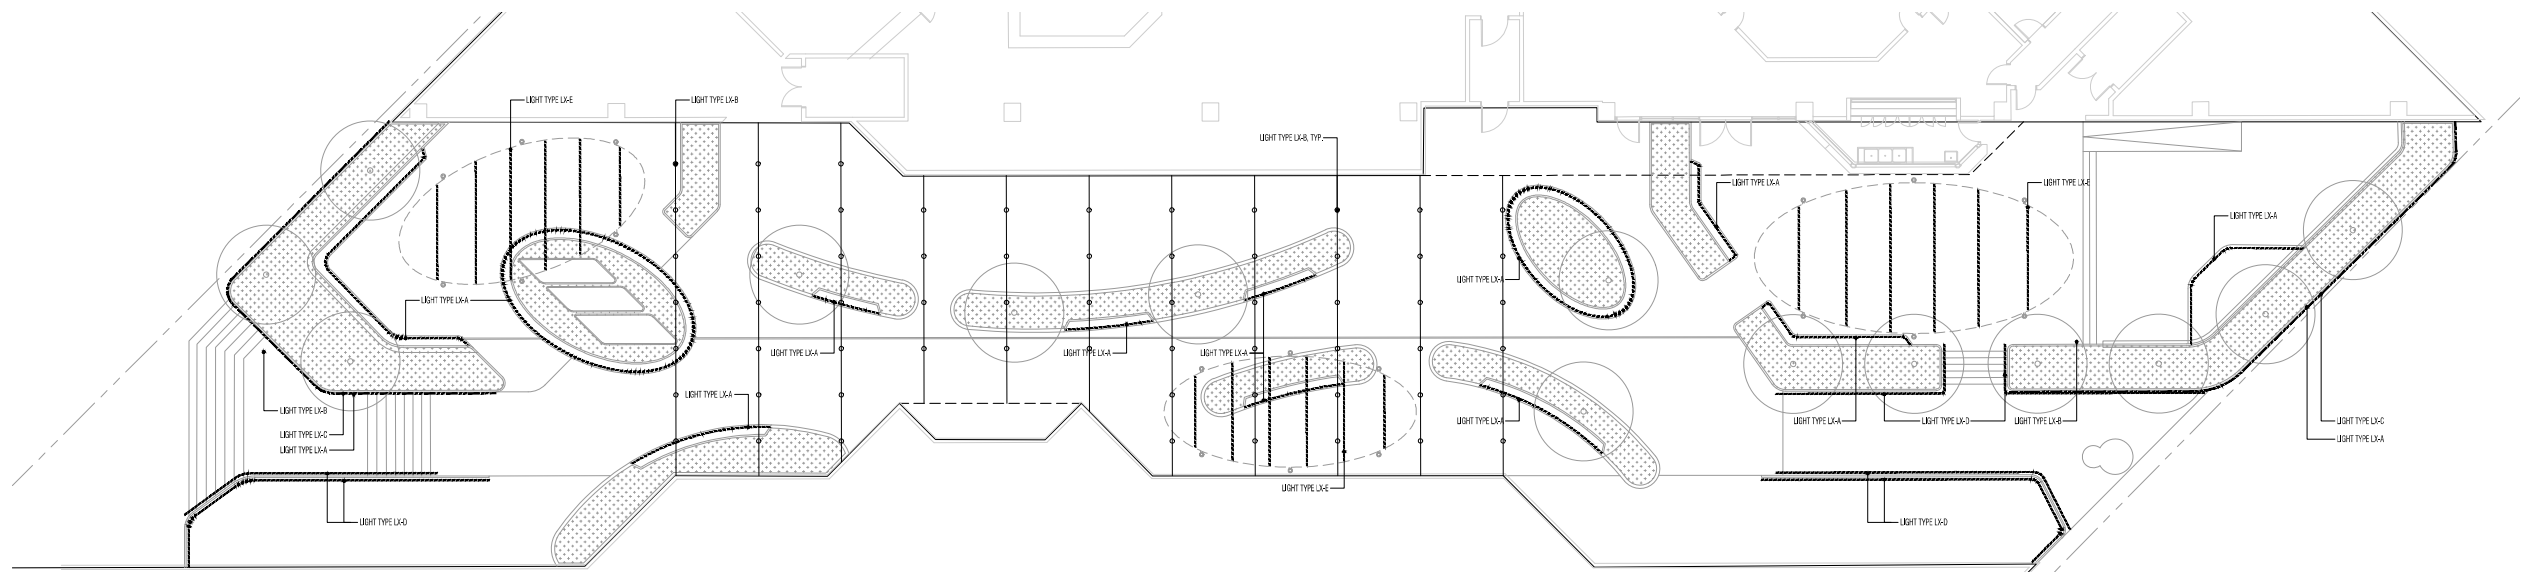

01 LIGHTING PLAN
3/2" = 1'-0"

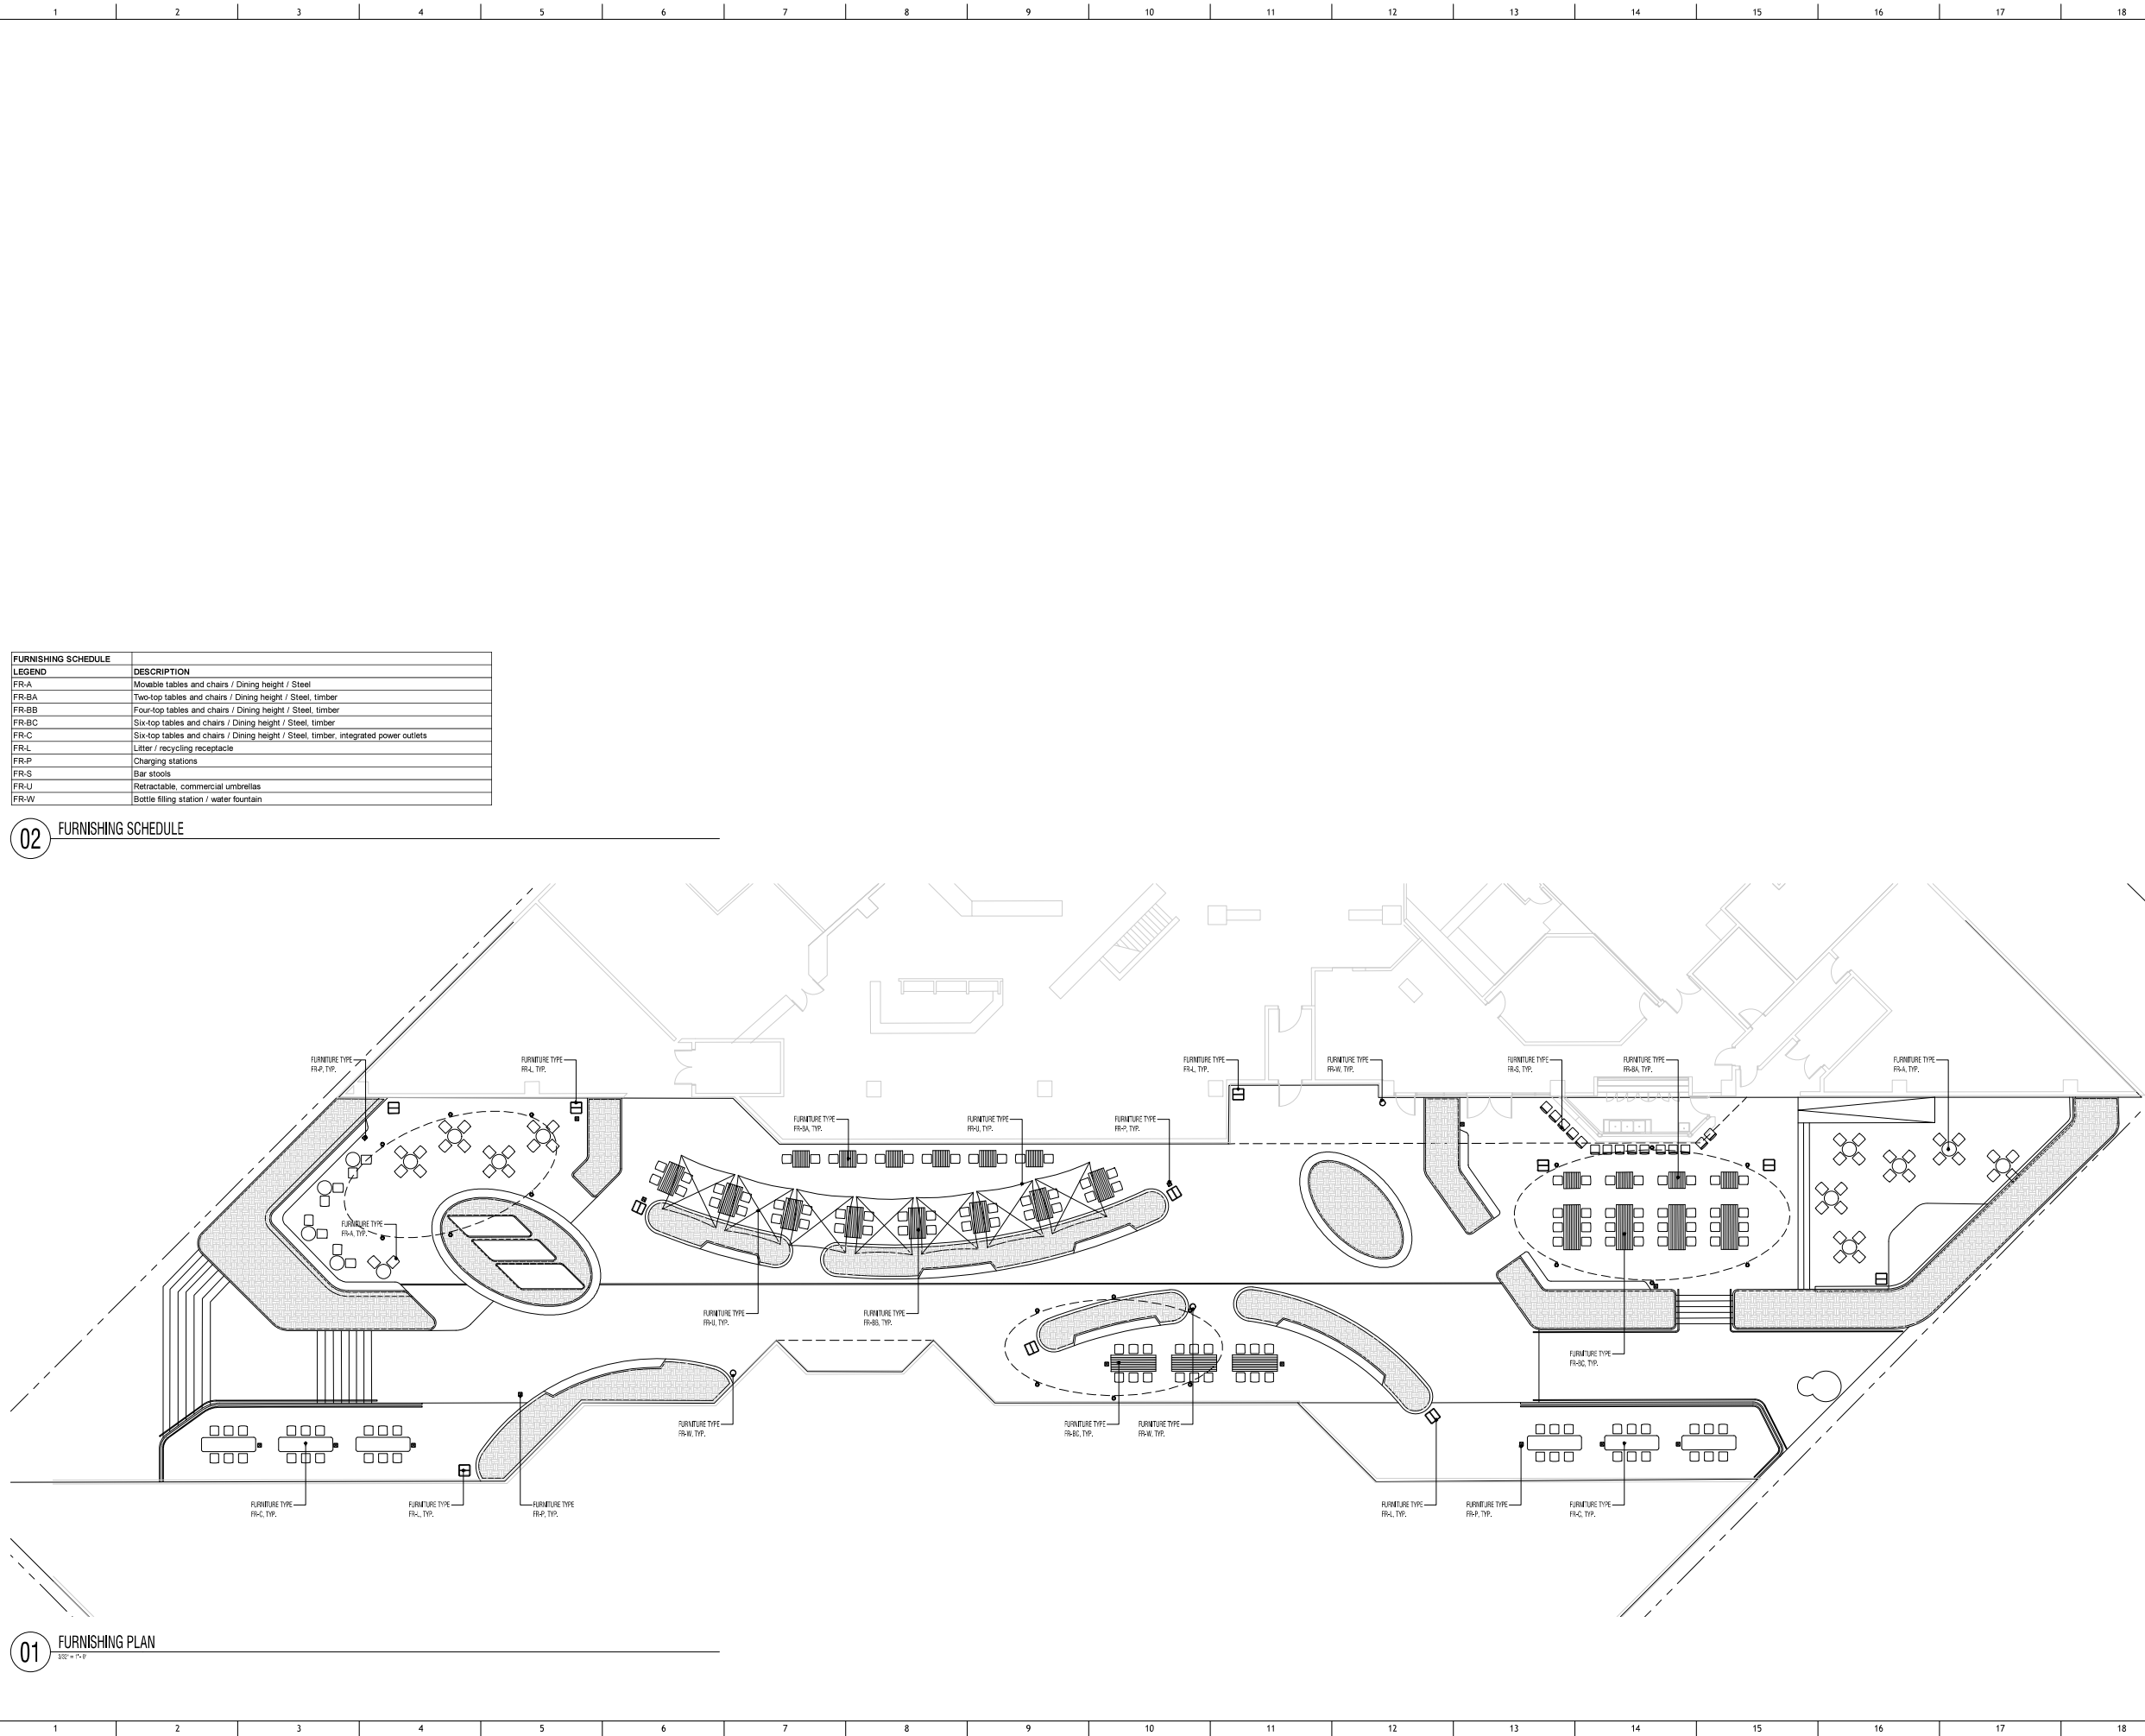 


FURNISHING SCHEDULE	
LEGEND	DESCRIPTION
FR-A	Moveable tables and chairs / Dining height / Steel
FR-BA	Two-top tables and chairs / Dining height / Steel, timber
FR-BB	Four-top tables and chairs / Dining height / Steel, timber
FR-BC	Six-top tables and chairs / Dining height / Steel, timber
FR-C	Six-top tables and chairs / Dining height / Steel, timber, integrated power outlets
FR-L	Litter / recycling receptacle
FR-P	Charging stations
FR-S	Bar stools
FR-U	Retractable, commercial umbrellas
FR-W	Bottle filling station / water fountain


02 FURNISHING SCHEDULE

01 FURNISHING PLAN


Project Name: 9/25/2021 3:58:05 PM
 General File Path: \\B:\360\360 Design\21-21300-00\Union Deaderick Plaza\Agencies\Furniture Design
 User: Tim Smith 888 180 0751 131200 000 Union Deaderick Plaza Union Deaderick Plaza - Union Deaderick Plaza

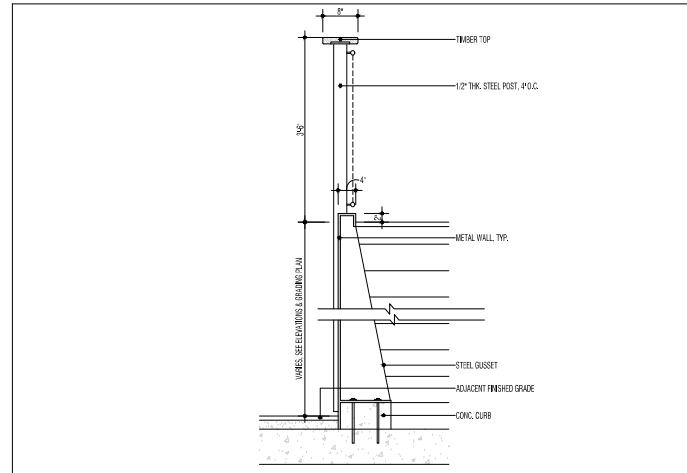


09 METAL WALL, TYP.
1/2" = 1'-0"

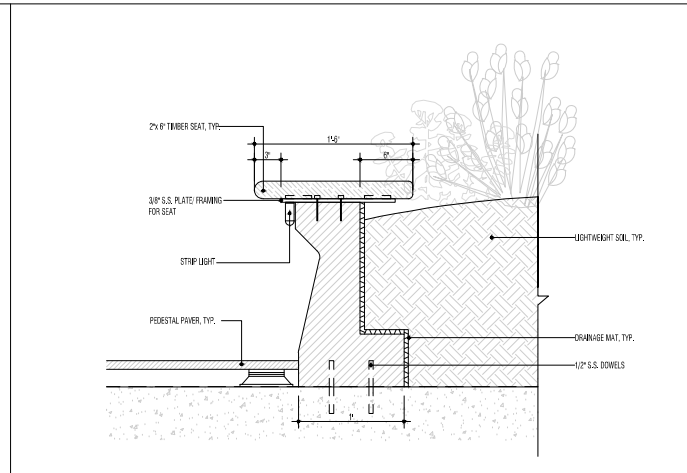


06 BENCH AT PRECAST PLANTER
1/12" = 1'-0"

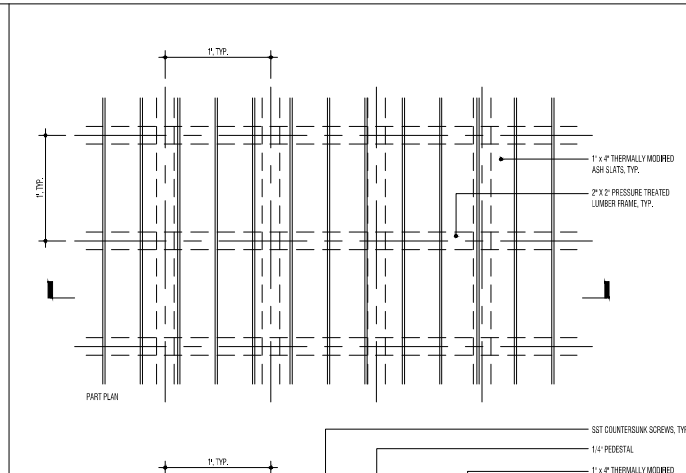


03 TIMBER DECKING
1/12" = 1'-0"

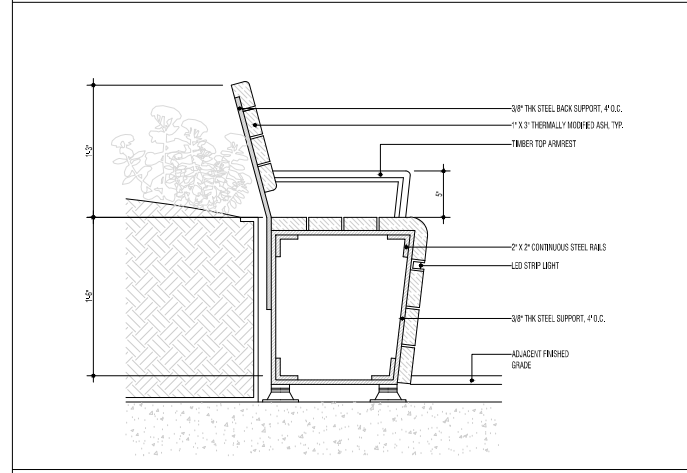


08 TIMBER BENCH, TYP.
1/12" = 1'-0"

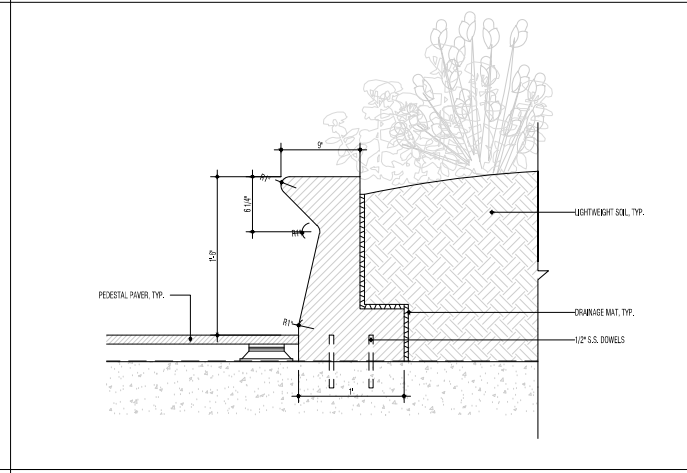


05 PRECAST PLANTER
1/12" = 1'-0"

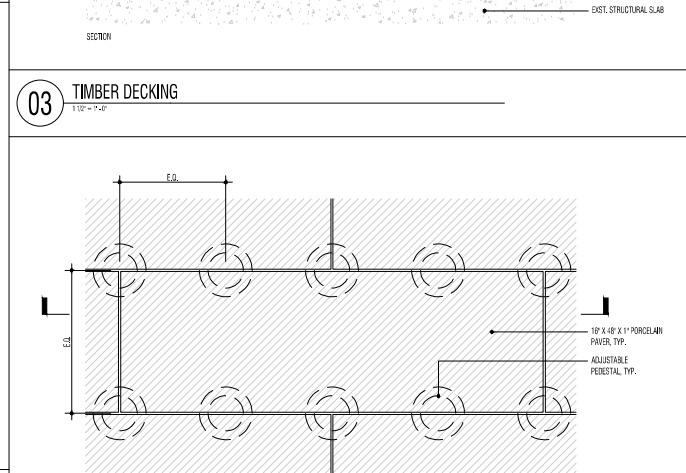


02 PAVER - PEDESTAL
1/12" = 1'-0"

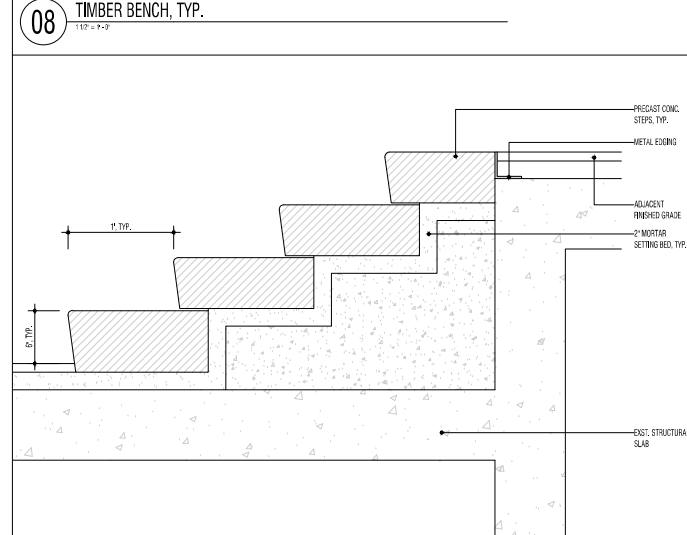


07 PRECAST STEPS
1/12" = 1'-0"

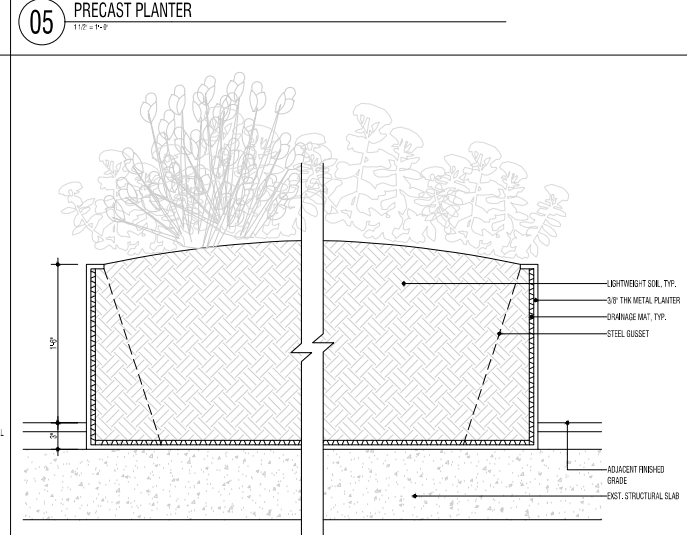

04 METAL PLANTER
1/12" = 1'-0"

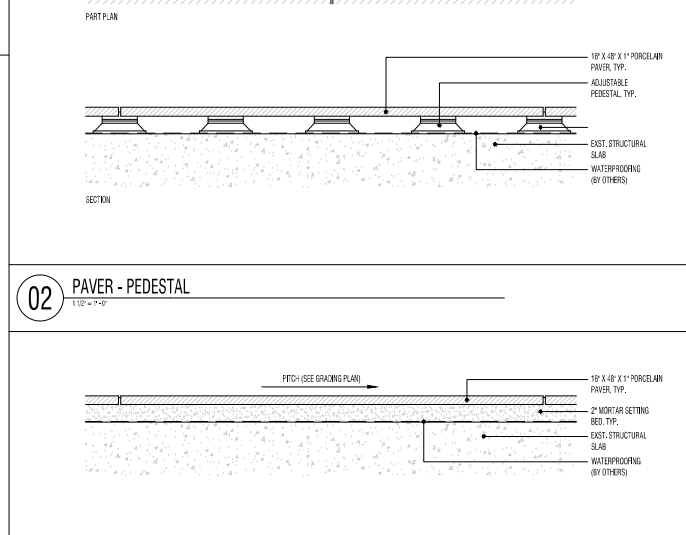

01 PAVER - MORTAR SETTING BED
1/12" = 1'-0"

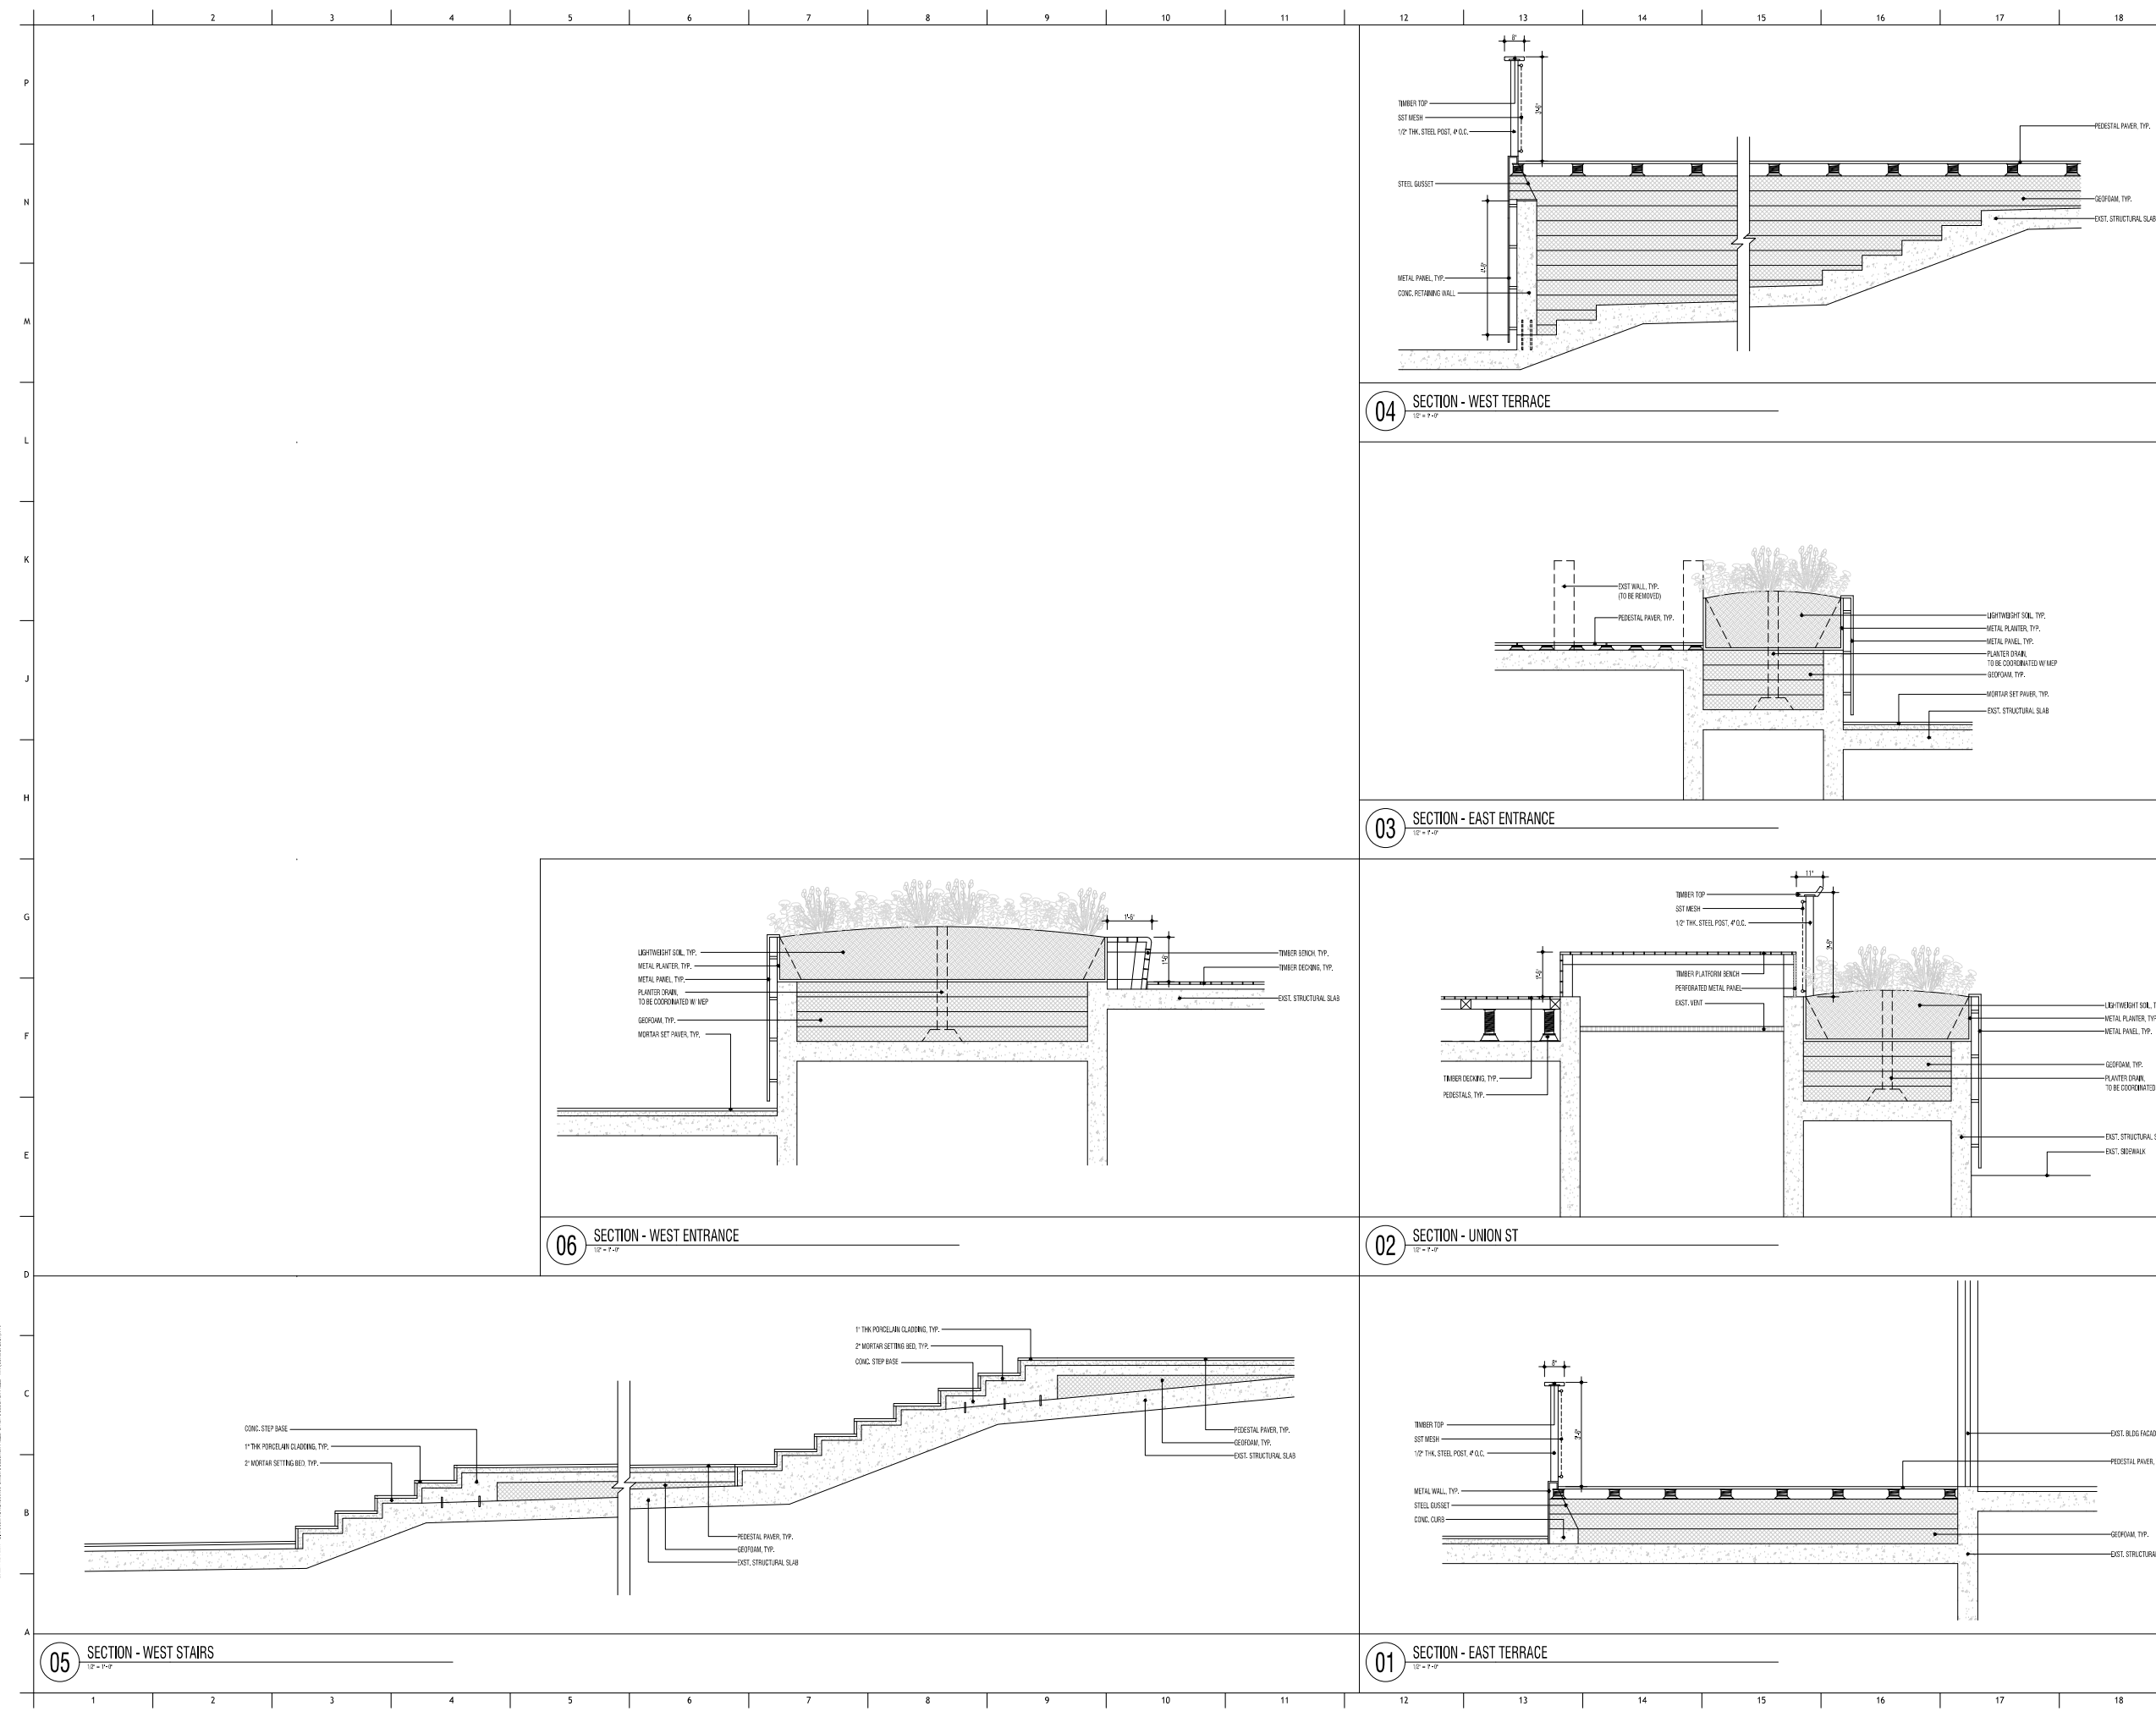

www.stgdesign.com
© 2019 Stg Design, Inc. All Rights Reserved

 
STG Design, Inc.
211 Union Street
Nashville, TN 37201
615.248.4400

PROGRESS PRINT
11/12/21
Not for regulatory approval,
permitting, or construction.
Regulator's Name: David Johnson, AIA
Tennessee Registration Number: 30564



Union Deaderick Plaza
Union and Deaderick
Nashville, TN 37219

CLIENT LOGO



2 100% DD 11/12/21
1 50% DD 10/15/21

Issues

Project Number: 21.21300.00
Project Lead: CJ

DETAILS

L-502

Plot Date: 11/12/2021 3:58:05 PM
 General File Path: \\BMS-3652-001\Design\21.21300.00\Union Deaderick Plaza\Project Files\05 - Progress Print\05 - Progress Print.dwg
 User: CJ
 Plot Path: \\BMS-3652-001\Design\21.21300.00\Union Deaderick Plaza\Print\05 - Progress Print.dwg